


ROHS-COMPLIANT

LTR	REV.	DESCRIPTION	DATE

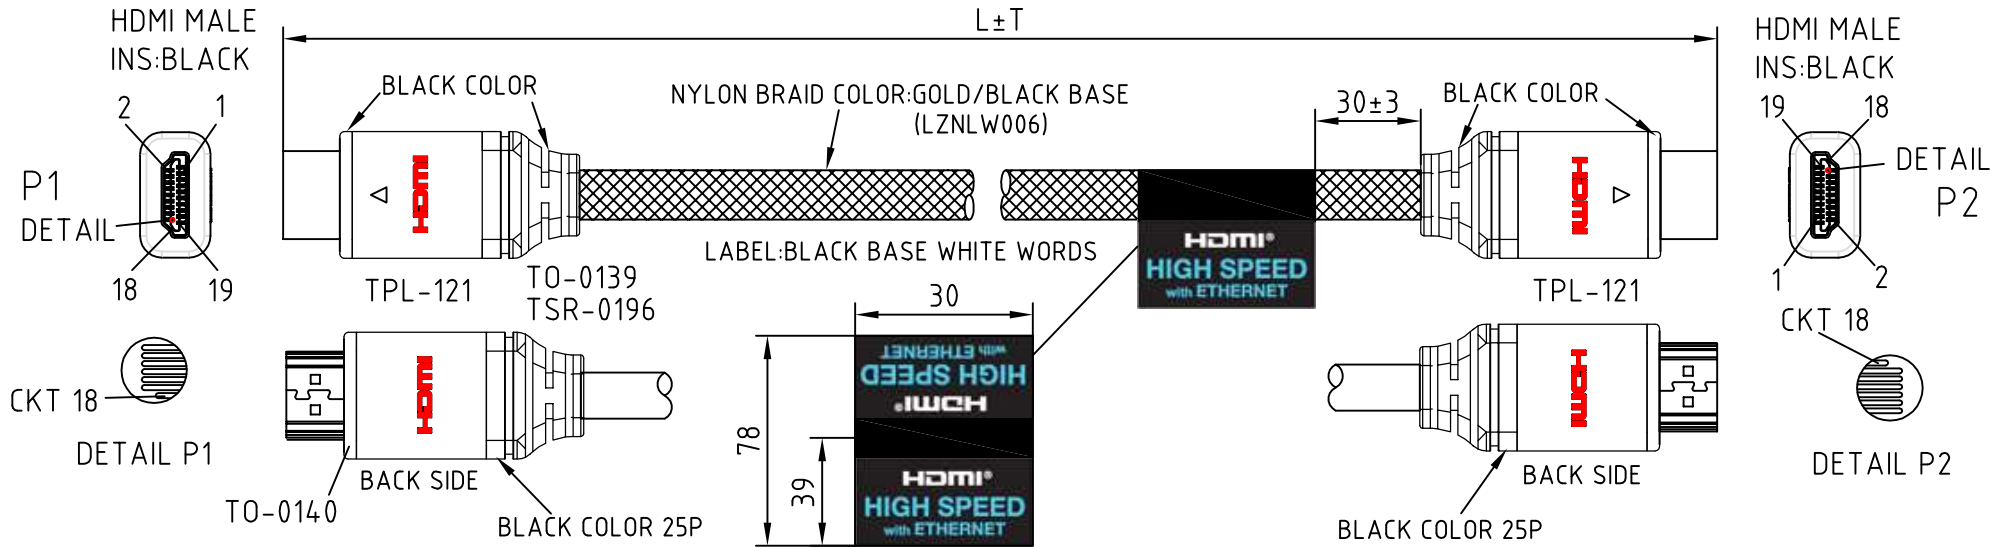

HDMI	PIN OUT	HDMI
P1		P2 CABLE FUNCTION
1	○	1 TMDS DATA 2+
3	○	3 TMDS DATA 2-
2	●	2 TMDS DATA 2 SHIELD
4	○	4 TMDS DATA 1+
6	○	6 TMDS DATA 1-
5	●	5 TMDS DATA 1 SHIELD
7	○	7 TMDS DATA 0+
9	○	9 TMDS DATA 0-
8	●	8 TMDS DATA 0 SHIELD
10	○	10 TMDS CLOCK +
12	○	12 TMDS CLOCK -
11	●	11 TMDS CLOCK SHIELD
14	○	14 UTILITY/HEAC+
19	○	19 HOT PLUG DETECT/HEAC-
17	●	17 DDC/CEC GROUND/HEAC SHIELD
13		13 CEC
15		15 SCL
16		16 SDA
18		18 +5V POWER
SHELL	B.D	SHELL GROUND

NOTE:

- CABLE: UL-20276 [#30(7/0.1 T.C)×1P INS:FOAM-PE+D.W(7/0.1 T.C) +AL/MY+MY]×5C+#30(7/0.1 T.C)×4C INS:Polyolefin+AL/MY +B.D(85%) PVC JACKET OD:6.5±0.15mm COLOR:BLACK(NK-K01) CABLE MUST PRINTED: High Speed HDMI™ Cable with Ethernet
- CONNECTOR: P1&P2: HDMI 19P MALE CONTACT:15u"; GOLD FLASH(1.8u") SHELL.
- HOOD: P1&P2:ASS'Y TYPE, ALUMINUM HOOD GOLD PLATED SR:MOLDED TYPE,PVC 45P,COLOR:BLACK(NK-K01) .
- ELECTRICAL TEST: (1)100% OPEN SHORT & MIS WIRE TEST. (2)CONTACT RESISTANCE 3 ohm Max . (3)INSULATION RESISTANCE 10M ohm Min .
- PACKING: EACH PC/POLYBAG+BIG HEADER CARD+BARCODE LABEL.

Tolerance Inch M/M			
.X	.015	.30	
.XX	.010	.10	
.XXX	.005	.05	
Draw			
200-1455-4	11.04.5505	5000±50	10
200-1455-3	11.04.5503	3000±30	20
200-1455-2	11.04.5502	2000±30	20
200-1455-1	11.04.5501	1000±20	20
DWG	P/N	L±T(mm)	PCS/CTN

Rotronic co., LTD.

Title
High Speed HDMI Cable with Ethernet

Customer P/N:

App'd _____ Customer: T-RAG

Scale NONE Units M/M Third Angle Projection

Dwg No. 200-1455 REV:A Sheet.1/1